



# BLACKBOY GRANNY FLAT FOR AMARCO MODULAR

PRELIMINARY CONSTRUCTION ISSUE

## DRAWING SCHEDULE


- A01 - TITLE / MODULAR LAYOUT
- A02 - FLOOR PLAN
- A03 - NORTH ELEVATION / EAST ELEVATION
- A04 - SOUTH ELEVATION / WEST ELEVATION
- A05 - SECTION A-A
- A06 - ELECTRICAL PLAN
- A07 - DRAINAGE PLAN
- A08 - STEEL STRUCTURE
- A09 - INTERNAL ELEVATIONS
- A10 - DECK AND PERGOLA

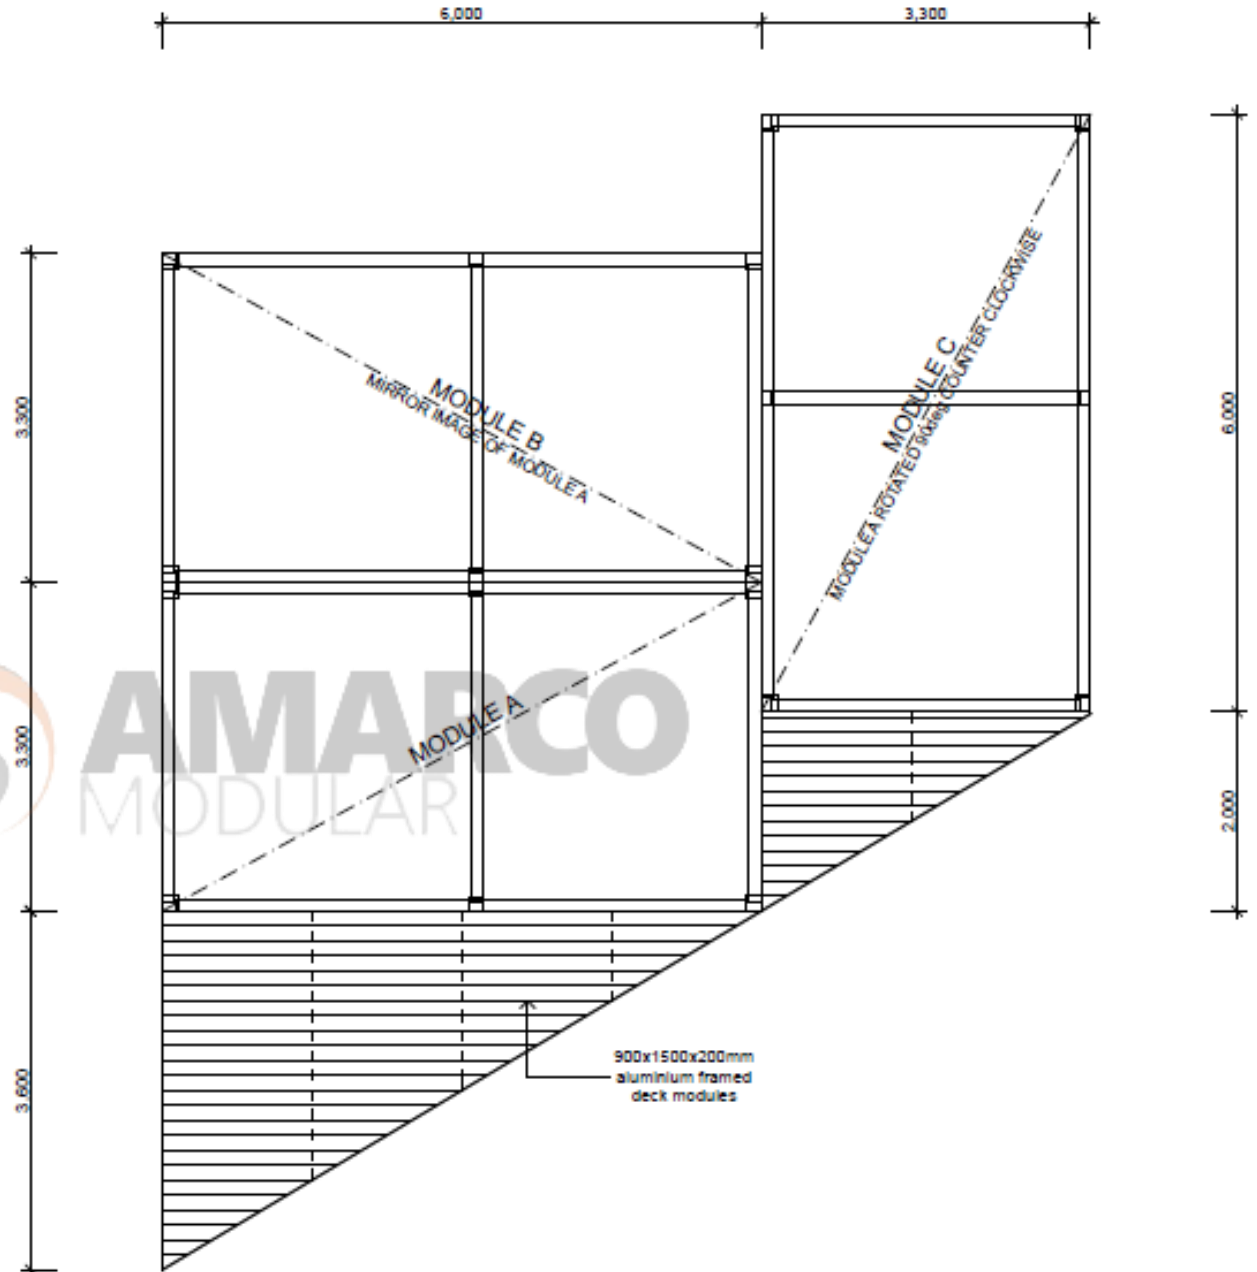

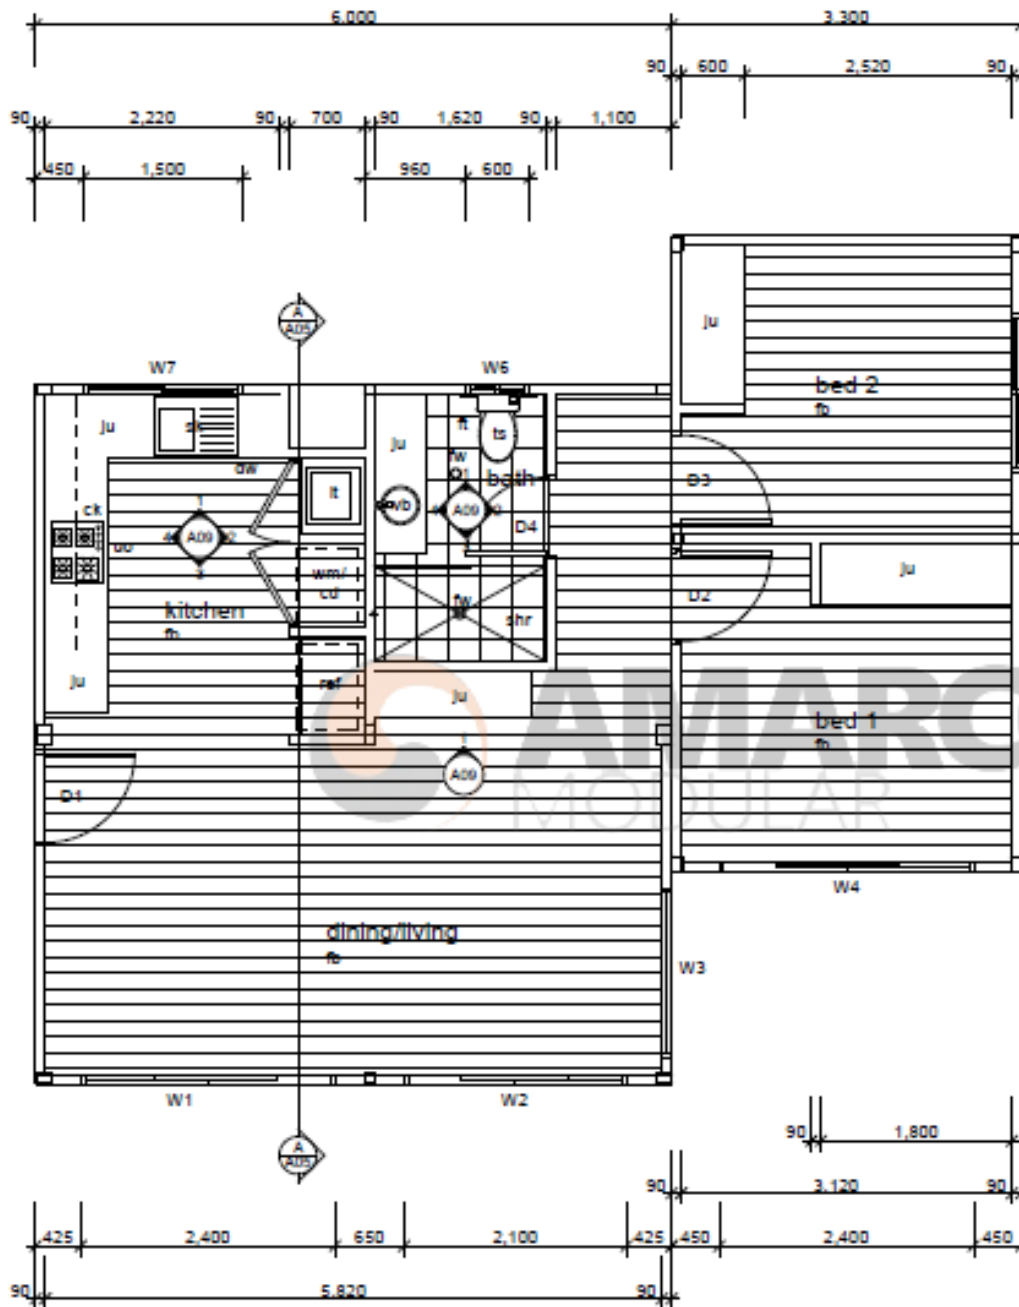

**LEGEND**

- ck cooktop
- cd clothes dryer
- D... door..
- dw dish washer
- fb floor boards
- fw floor waste
- ft floor tiles
- ju joinery unit
- lt laundry tub
- ref refrigerator
- shr shower
- sk sink
- ts toilet suite
- uo underbench oven
- vb vanity basin
- W... window..
- wm washing machine

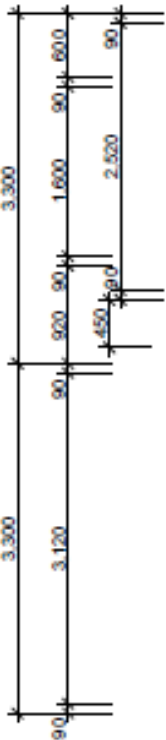

**AMARCO**  
MODULAR  
M: +61433453464  
[colin@amarco.com.au](mailto:colin@amarco.com.au)

ALL DIMENSIONS ARE IN MILLIMETRES UNLESS SHOWN OTHERWISE.  
ALL LEVELS ARE IN METRES TO AHD UNLESS SHOWN OTHERWISE.  
WORK TO WRITTEN DIMENSIONS. DO NOT SCALE FROM DRAWINGS.  
CHECK ALL DIMENSIONS ON SITE AND REPORT ANY DISCREPANCIES  
PRIOR TO CONSTRUCTION OR FABRICATION OF ANY ITEM.

THIS DRAWING IS TO BE READ IN CONJUNCTION WITH THE TOTAL  
DOCUMENTATION PACKAGE.

No. REVISION  
1 PRELIMINARY FOR CONSTRUCTION

DATE




BLACKBOY GRANNY FLAT  
FOR:



**FLOOR  
PLAN**

SCALE 1:50  
REVISION 1  
DATE 24/09/2013  
PROJECT 109-1


**A02**

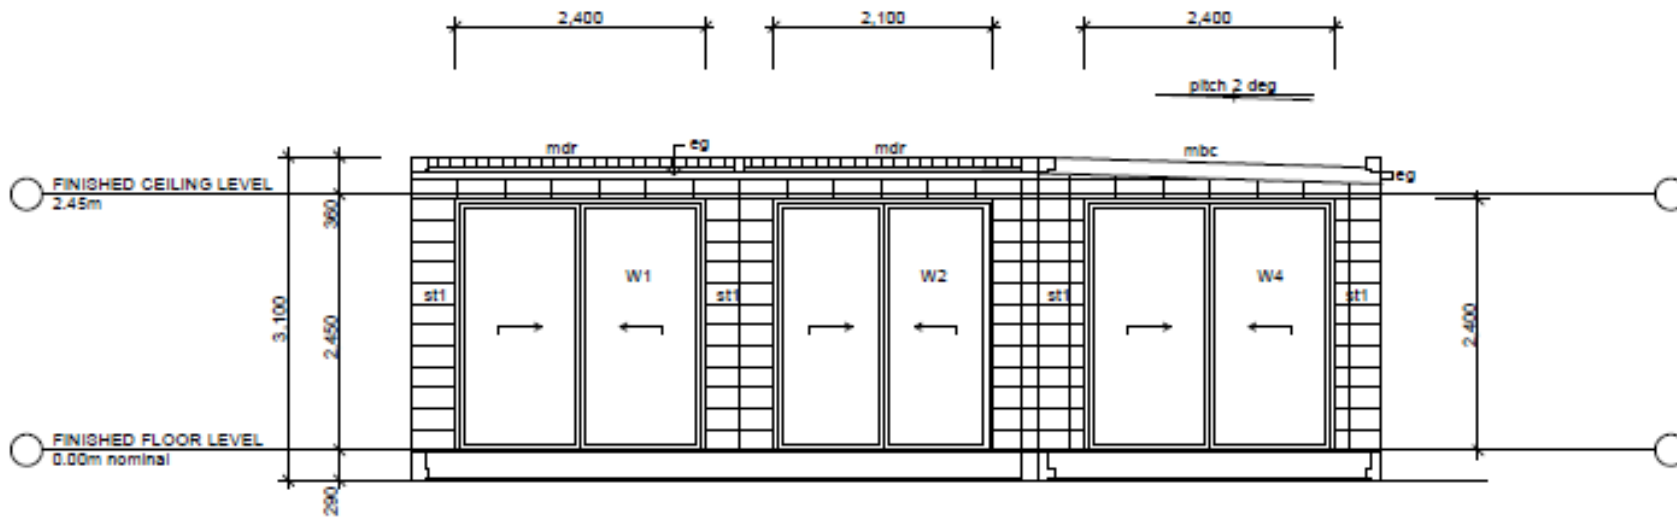

**LEGEND**

- ac air conditioner
- D.. door..
- eg eaves gutter
- hw hot water system
- mbc metal barge capping
- mdr metal deck roofing
- st.. stone cladding type..
- wb weatherboards
- W.. window..

**NORTH**

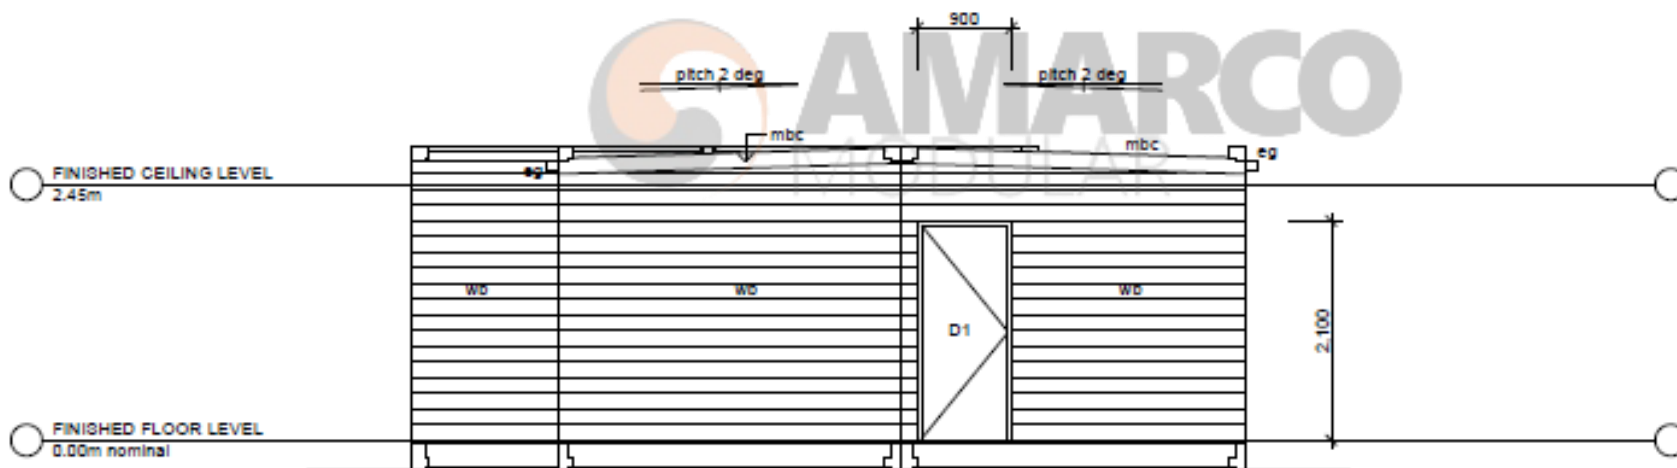

**EAST**



M: +61433453464

[colin@amarco.com.au](mailto:colin@amarco.com.au)

ALL DIMENSIONS ARE IN MILLIMETRES UNLESS SHOWN OTHERWISE. ALL LEVELS ARE IN METRES TO AHD UNLESS SHOWN OTHERWISE. WORK TO WRITTEN DIMENSIONS. DO NOT SCALE FROM DRAWINGS. CHECK ALL DIMENSIONS ON SITE AND REPORT ANY DISCREPANCIES PRIOR TO CONSTRUCTION OR FABRICATION OF ANY ITEM.

THIS DRAWING IS TO BE READ IN CONJUNCTION WITH THE TOTAL DOCUMENTATION PACKAGE.

No. REVISION  
1 PRELIMINARY FOR CONSTRUCTION

DATE


BLACKBOY GRANNY FLAT  
FOR:



**NORTH  
ELEVATION  
EAST  
ELEVATION**


SCALE 1:50  
REVISION 1  
DATE 24/09/2013  
PROJECT 109-1

**A03**

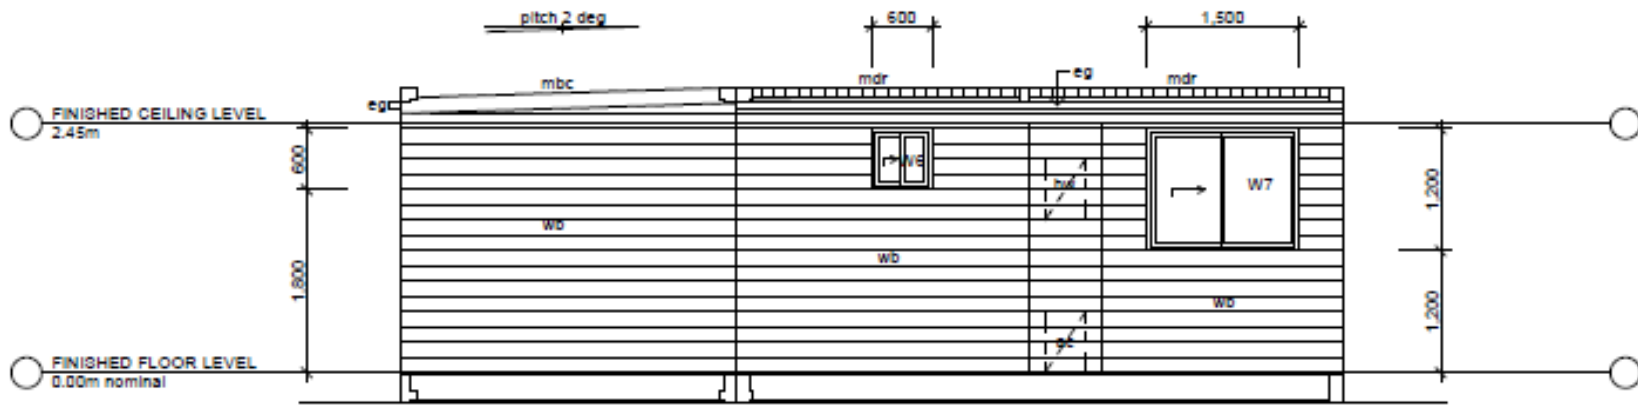


- LEGEND**
- ac air conditioner
  - D.. door..
  - eg eaves gutter
  - hw hot water system
  - mbc metal barge capping
  - mdr metal deck roofing
  - st.. stone cladding type..
  - wb weatherboards
  - W.. window..

**SOUTH**

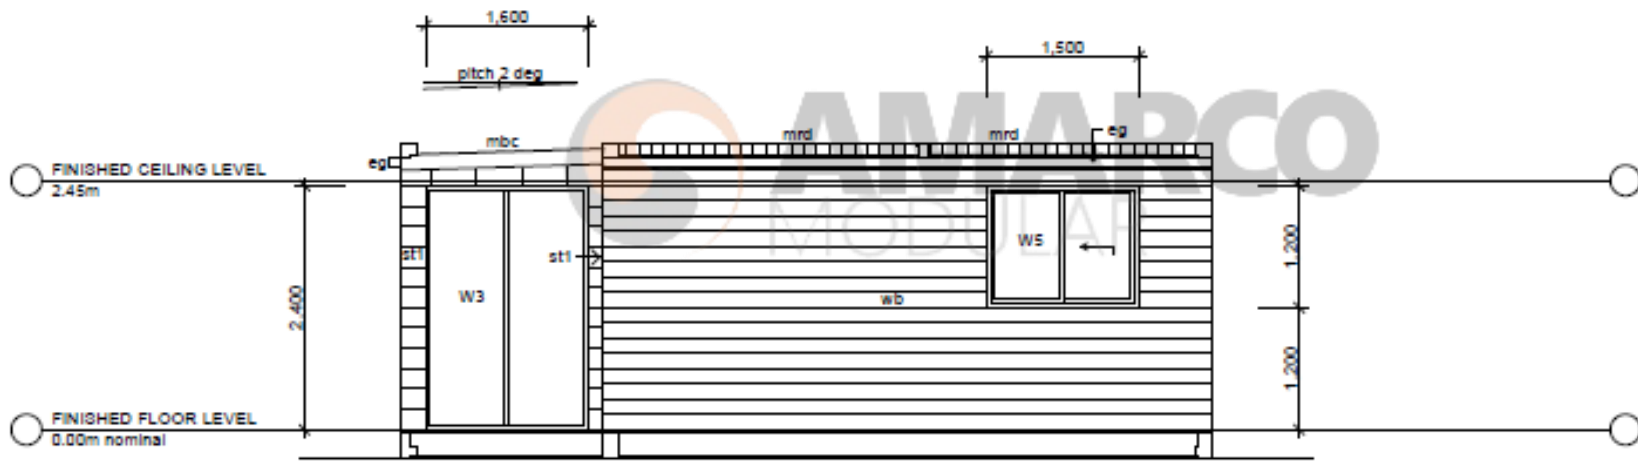

**WEST**

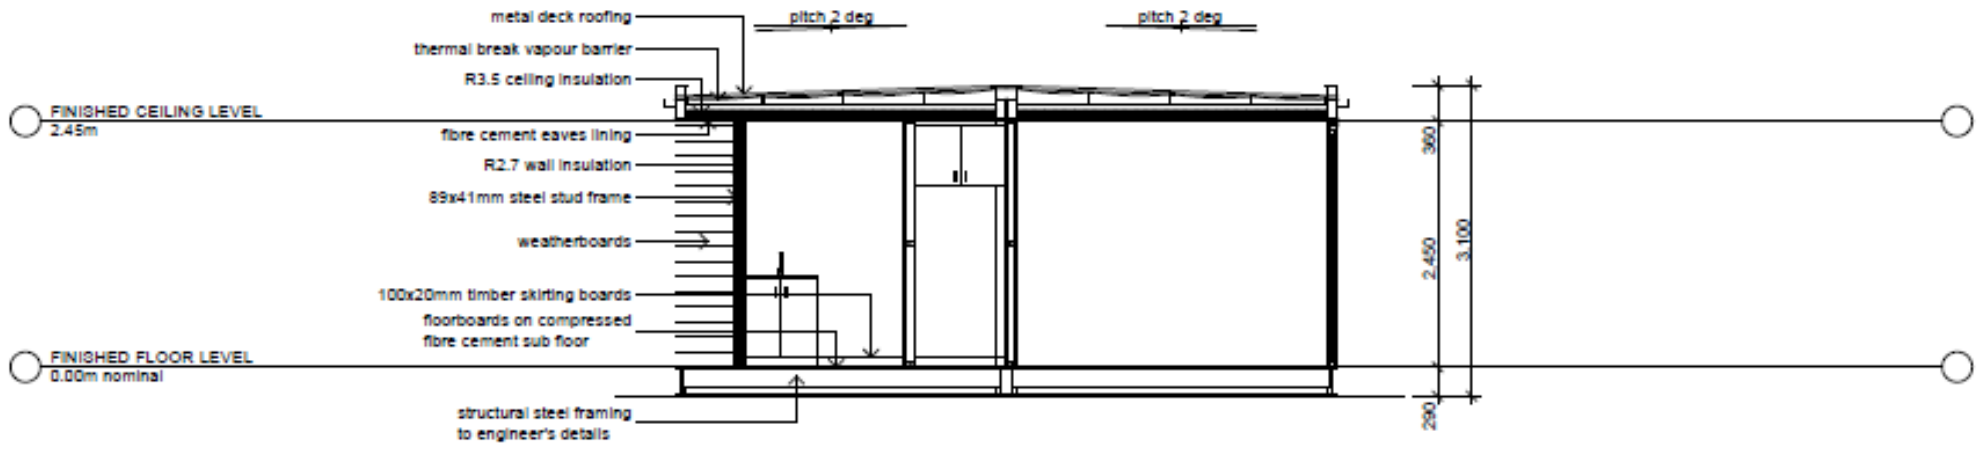

**AMARCO**  
MODULAR  
M: +61433453464  
[colin@amarco.com.au](mailto:colin@amarco.com.au)

ALL DIMENSIONS ARE IN MILLIMETRES UNLESS SHOWN OTHERWISE.  
ALL LEVELS ARE IN METRES TO AHD UNLESS SHOWN OTHERWISE.  
WORK TO WRITTEN DIMENSIONS. DO NOT SCALE FROM DRAWINGS.  
CHECK ALL DIMENSIONS ON SITE AND REPORT ANY DISCREPANCIES  
PRIOR TO CONSTRUCTION OR FABRICATION OF ANY ITEM.  
  
THIS DRAWING IS TO BE READ IN CONJUNCTION WITH THE TOTAL  
DOCUMENTATION PACKAGE.

No.	REVISION	DATE
1	PRELIMINARY FOR CONSTRUCTION	

**BLACKBOY GRANNY FLAT**  
FOR:  
**AMARCO**  
MODULAR


**SECTION A-A**

SCALE 1:50  
REVISION 1  
DATE 24/09/2013  
PROJECT 109-1

**A05**

**LEGEND**

- ◆ interior downlight
- bathroom light fitting
- ⊗ flush mount ceiling light
- ▶ double power outlet
- ⊠ wall exhaust fan
- ┆ mirror light
- × switch
- ⊖ external light
- ◁ data outlet
- ▲ tv outlet
- smoke detector
- passive infrared sensor
- BC air conditioner
- CD clothes dryer
- CK cooktop
- HW hot water system
- MW microwave
- RF refrigerator
- SB switchboard
- UC underbench oven
- WTW washing machine

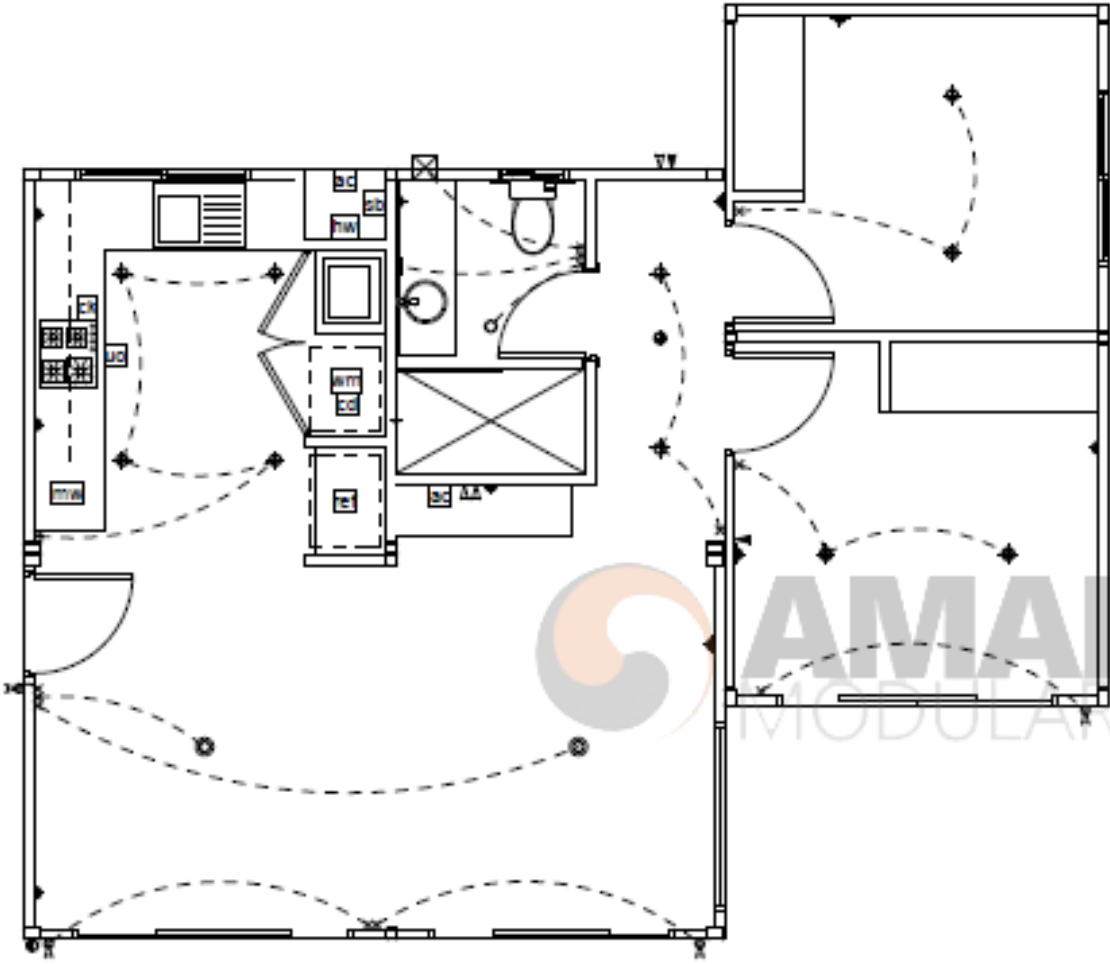

**AMARCO**  
MODULAR  
M: +61433453464  
[colin@amarco.com.au](mailto:colin@amarco.com.au)

ALL DIMENSIONS ARE IN MILLIMETRES UNLESS SHOWN OTHERWISE.  
ALL LEVELS ARE IN METRES TO AHD UNLESS SHOWN OTHERWISE.  
WORK TO WRITTEN DIMENSIONS. DO NOT SCALE FROM DRAWINGS.  
CHECK ALL DIMENSIONS ON SITE AND REPORT ANY DISCREPANCIES  
PRIOR TO CONSTRUCTION OR FABRICATION OF ANY ITEM.  
  
THIS DRAWING IS TO BE READ IN CONJUNCTION WITH THE TOTAL  
DOCUMENTATION PACKAGE.

No. REVISION DATE  
1 PRELIMINARY FOR CONSTRUCTION





**BLACKBOY GRANNY FLAT**  
FOR: **AMARCO**  
MODULAR

**ELECTRICAL**  
**PLAN**

SCALE 1:50  
REVISION 1  
DATE 24/09/2013  
PROJECT 109-1

**A06**

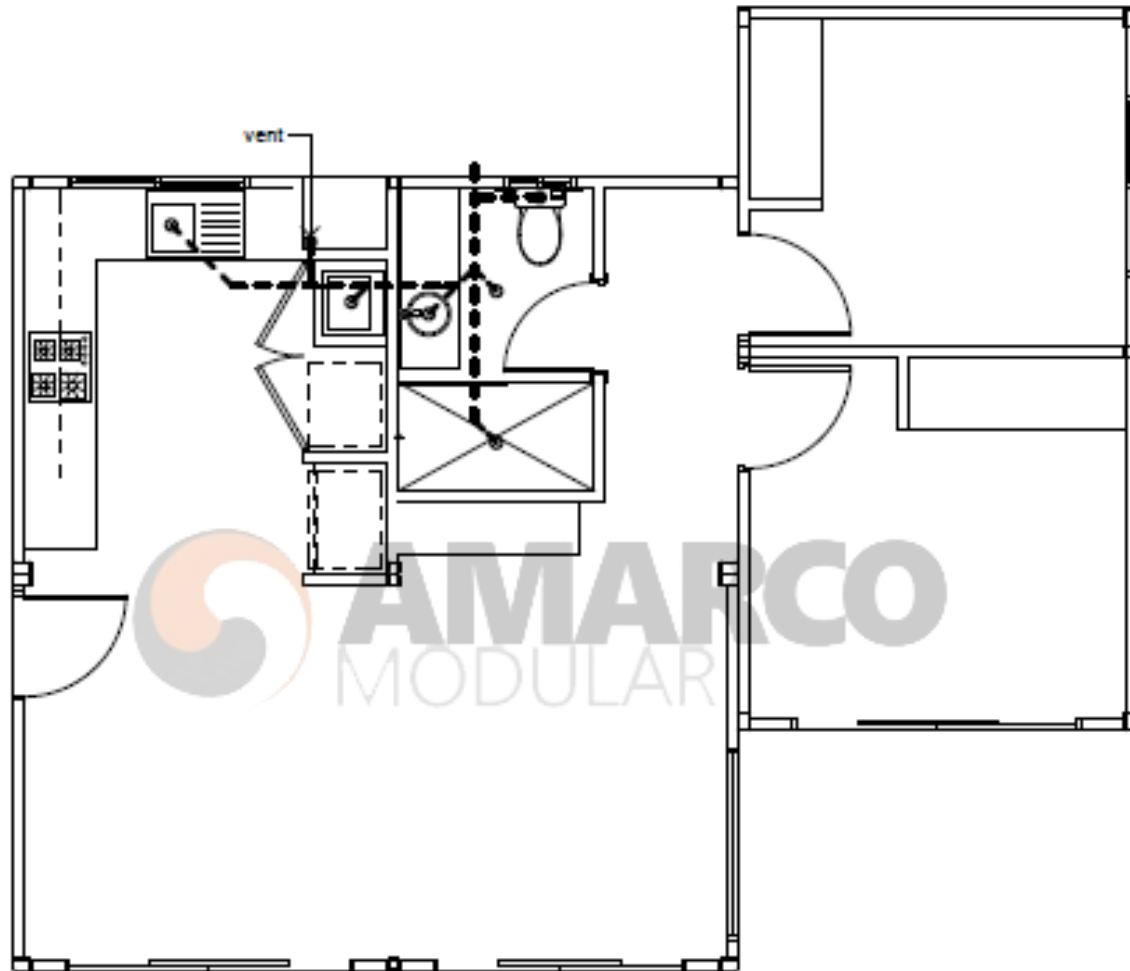

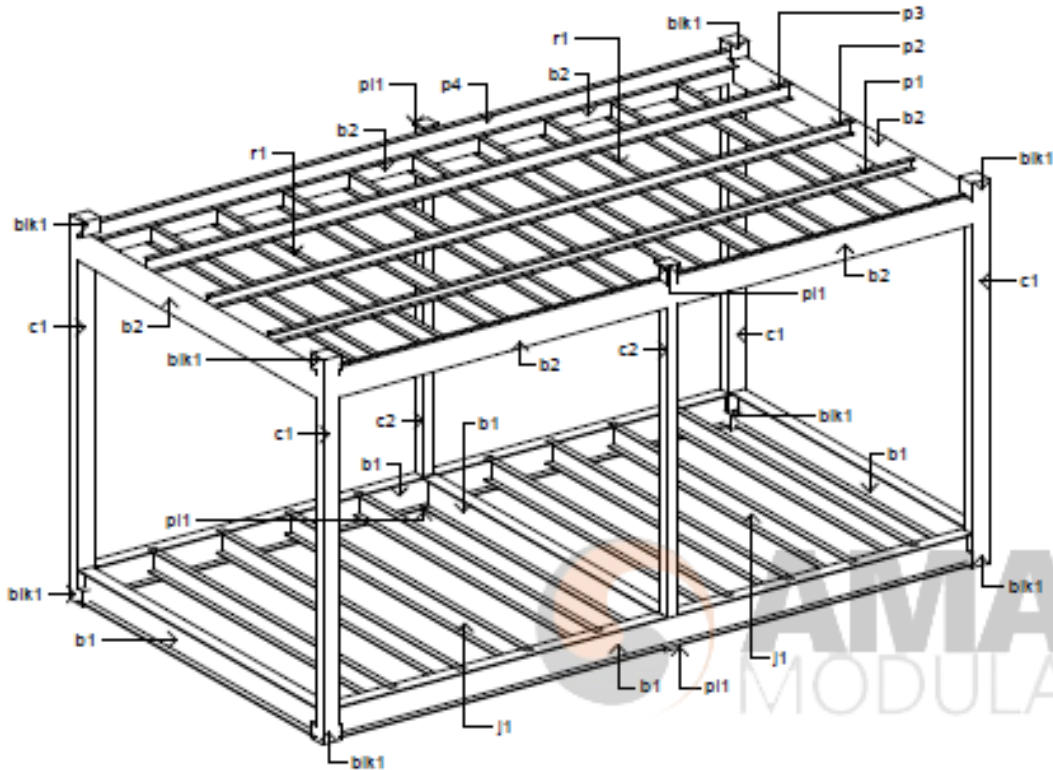


### LEGEND

b1	H250x125x6x9
b2	RH9200x100x3
blk1	PL119x163
c1	RH9150x100x5
c2	RH9100x100x5
j1	C180x60x2
p1	C80x50x2
p2	C100x50x2
p3	C120x50x2
p4	C150x50x2
pl1	PL20x130
r1	C150x50x2

NOTE: DIAGRAM FOR PRICING PURPOSES ONLY. ALL STRUCTURAL ELEMENTS AND FIXING METHODS MUST BE CHECKED AND CERTIFIED BY A QUALIFIED STRUCTURAL ENGINEER BEFORE FABRICATION OF ANY ITEM.



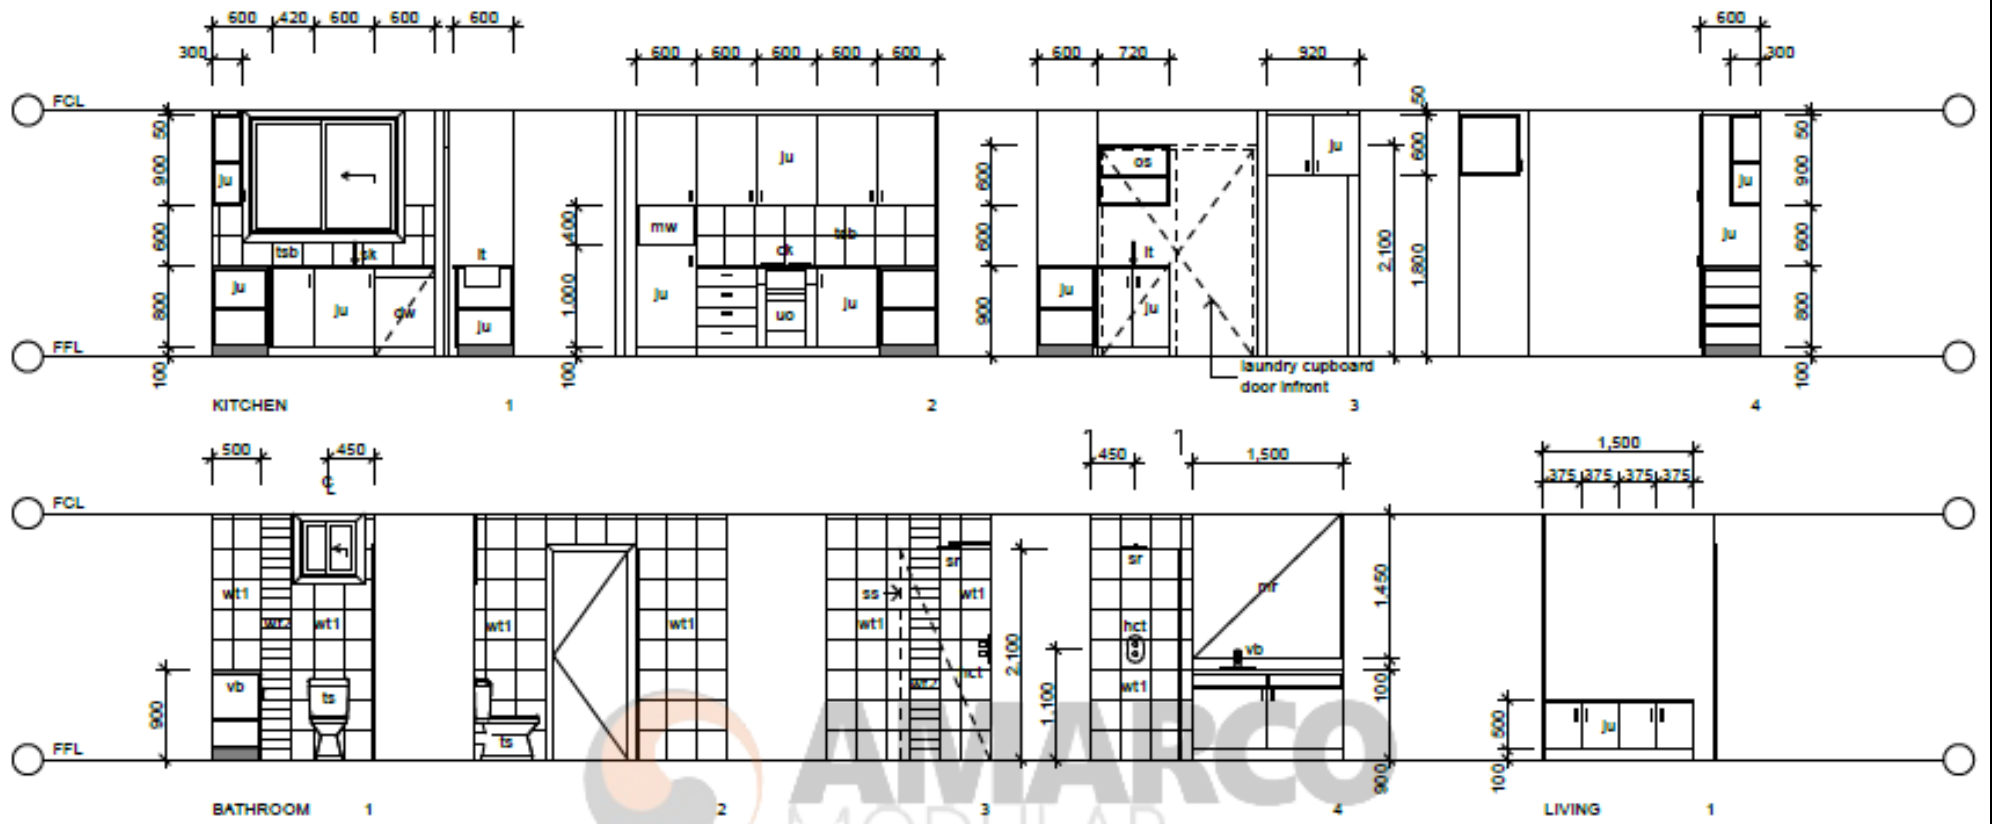

**LEGEND**

- ck      cooktop
- dw      dishwasher
- hct     hot and cold taps
- ju      joinery unit
- it      laundry tub
- mr      mirror
- mw     microwave
- os      open shelves
- sk      sink
- sr      shower rose
- ss      glass shower screen
- ts      toilet suite
- tsb     tiled splash back
- uo      under bench oven
- wt..    wall tile..

